

ALL CLIENTS INFOREMATION HAS BEEN REMOVED FROM THIS DRAWING.


GENERAL NOTES

1. THE CONTRACTOR SHALL PROVIDE ALL NECESSARY BENDS, OFFSETS, FITTINGS, ETC. TO SUIT THE INSTALLATION AND BUILDING CONSTRUCTION AND CO-ORDINATE FINAL ROUTES WITH ALL OTHER TRADES/SERVICES.
2. ALL EXISTING SERVICES POSITIONS AND SIZES ARE APPROXIMATE ONLY.
3. THE DRAWING DOES NOT INDICATE THE PRESENCE OF ALL SERVICES EXISTING ON SITE AND IS TO BE READ IN CONJUNCTION WITH THE MECHANICAL & ELECTRICAL SERVICES SPECIFICATION AND DRAWINGS.
4. THIS DRAWING IS TO BE READ IN CONJUNCTION WITH THE PROJECT SPECIFICATION AND DRAWINGS. ALL SERVICES ARE SHOWN INDICATIVE ONLY. THE CONTRACTOR SHALL LIAISE FULLY ON SITE WITH ALL OTHER TRADES TO ENSURE THAT ALL SERVICES CAN BE INSTALLED CORRECTLY. NO SERVICES ARE TO BE INSTALLED PRIOR TO THE PRODUCTION OF FULLY CO-ORDINATE WORKING DRAWINGS.

LIGHTING NOTES

1. ALL ACCESSORY/EQUIPMENT POSITIONS ARE INDICATIVE ONLY. THE CONTRACTOR IS TO OBTAIN APPROVAL FROM THE PROJECT MANAGER FOR ANY CHANGE FROM DETAILED LAYOUTS PRIOR TO THE INSTALLATION.
2. REFER TO LUMINAIRE LEGEND FOR LUMINAIRE TYPES.
3. ALL EMERGENCY EXIT SIGN LUMINAIRES ARE TO BE LOCATED IN ACCORDANCE WITH WITH BS5266-1:2016. THIS DESIGN IS NOT A SAFE ACCREDITED DESIGN.
4. NEW CABLES ARE TO BE ROUTED ALONG EXISTING CABLE ROUTES, WHERE POSSIBLE, AND IN SUCH A WAY AS TO NOT DISTRACT FROM THE BUILDINGS AESTHETICS.
5. CABLES RUN IN PARTITION WALLS & CEILING VOIDS ARE TO COMPLY WITH REGULATIONS 522-06-05 & 522-06-06 OF BS7671.
6. ALL POSITIONS OF FITTINGS TO BE COORDINATED WITH ALL OTHER SERVICES ON SITE BY THE CONTRACTOR.
7. INTERNAL LIGHTING IS TO BE CONTROLLED BY EXISTING LIGHT SWITCHES, WITH LOAD TRANSFER RELAYS INSTALLED FOR THE UPS BACKED UP FITTINGS.
8. EXTERNAL LUMINAIRES ARE TO BE CONTROLLED BY PIR AND AMBIENT LIGHT DETECTION. EXACT QUANTITIES AND LOCATIONS OF SENSORS SHALL BE DETERMINED BY THE CONTRACTOR.

| LUMINAIRE SCHEDULE | | | | | | |
|--|----------|----------|-----------------|------------|-----------|----------------|
| IDENTIFICATION | MAKE | MODEL | TYPE | RATING (W) | TOTAL | PRODUCT INFO |
| CY-01 | TAMLITE | CYCLONE | P 4000K, 3100lm | 22W | 9 | CYP4310NW |
| SL-01 | TAMLITE | SOLAR S | 4000K, 2200lm | 19W | 22 | SLRS220NW |
| BL-01 | TAMLITE | CITY BL | 4000K, 900lm | 9W | 10 | CBL90NW |
| TB-01 | TAMLITE | TBX | 4000K, 2500lm | 16W | 8 | TBX4250NW |
| EL-01 | TAMLITE | ELITE TS | 4000K, 760lm | 10W | 2 | ELTNM3 |
| EX-01 | TAMLITE | EXPO | 4000K, 12100lm | 78W | 24 | EXP1200WBNW |
| SS-01 | SPURLITE | SPOCK | 4000K, 811lm | 12W | 4 | SPOCK75 541002 |
| EXP-01 | TAMLITE | EXPLORER | 4000K, 4800lm | 40W | 5 | EXPFLDA480NW |
| TA-32 | SPURLITE | LED TAPE | 4000K, 900lm | 10W | 32 METRES | - |
| | SPURLITE | WEX | RUNNING MAN | 5W | 7 | WEX BRASS |
| E DENOTES EMERGENCY MAINTAINED FITTING | | | | | | |

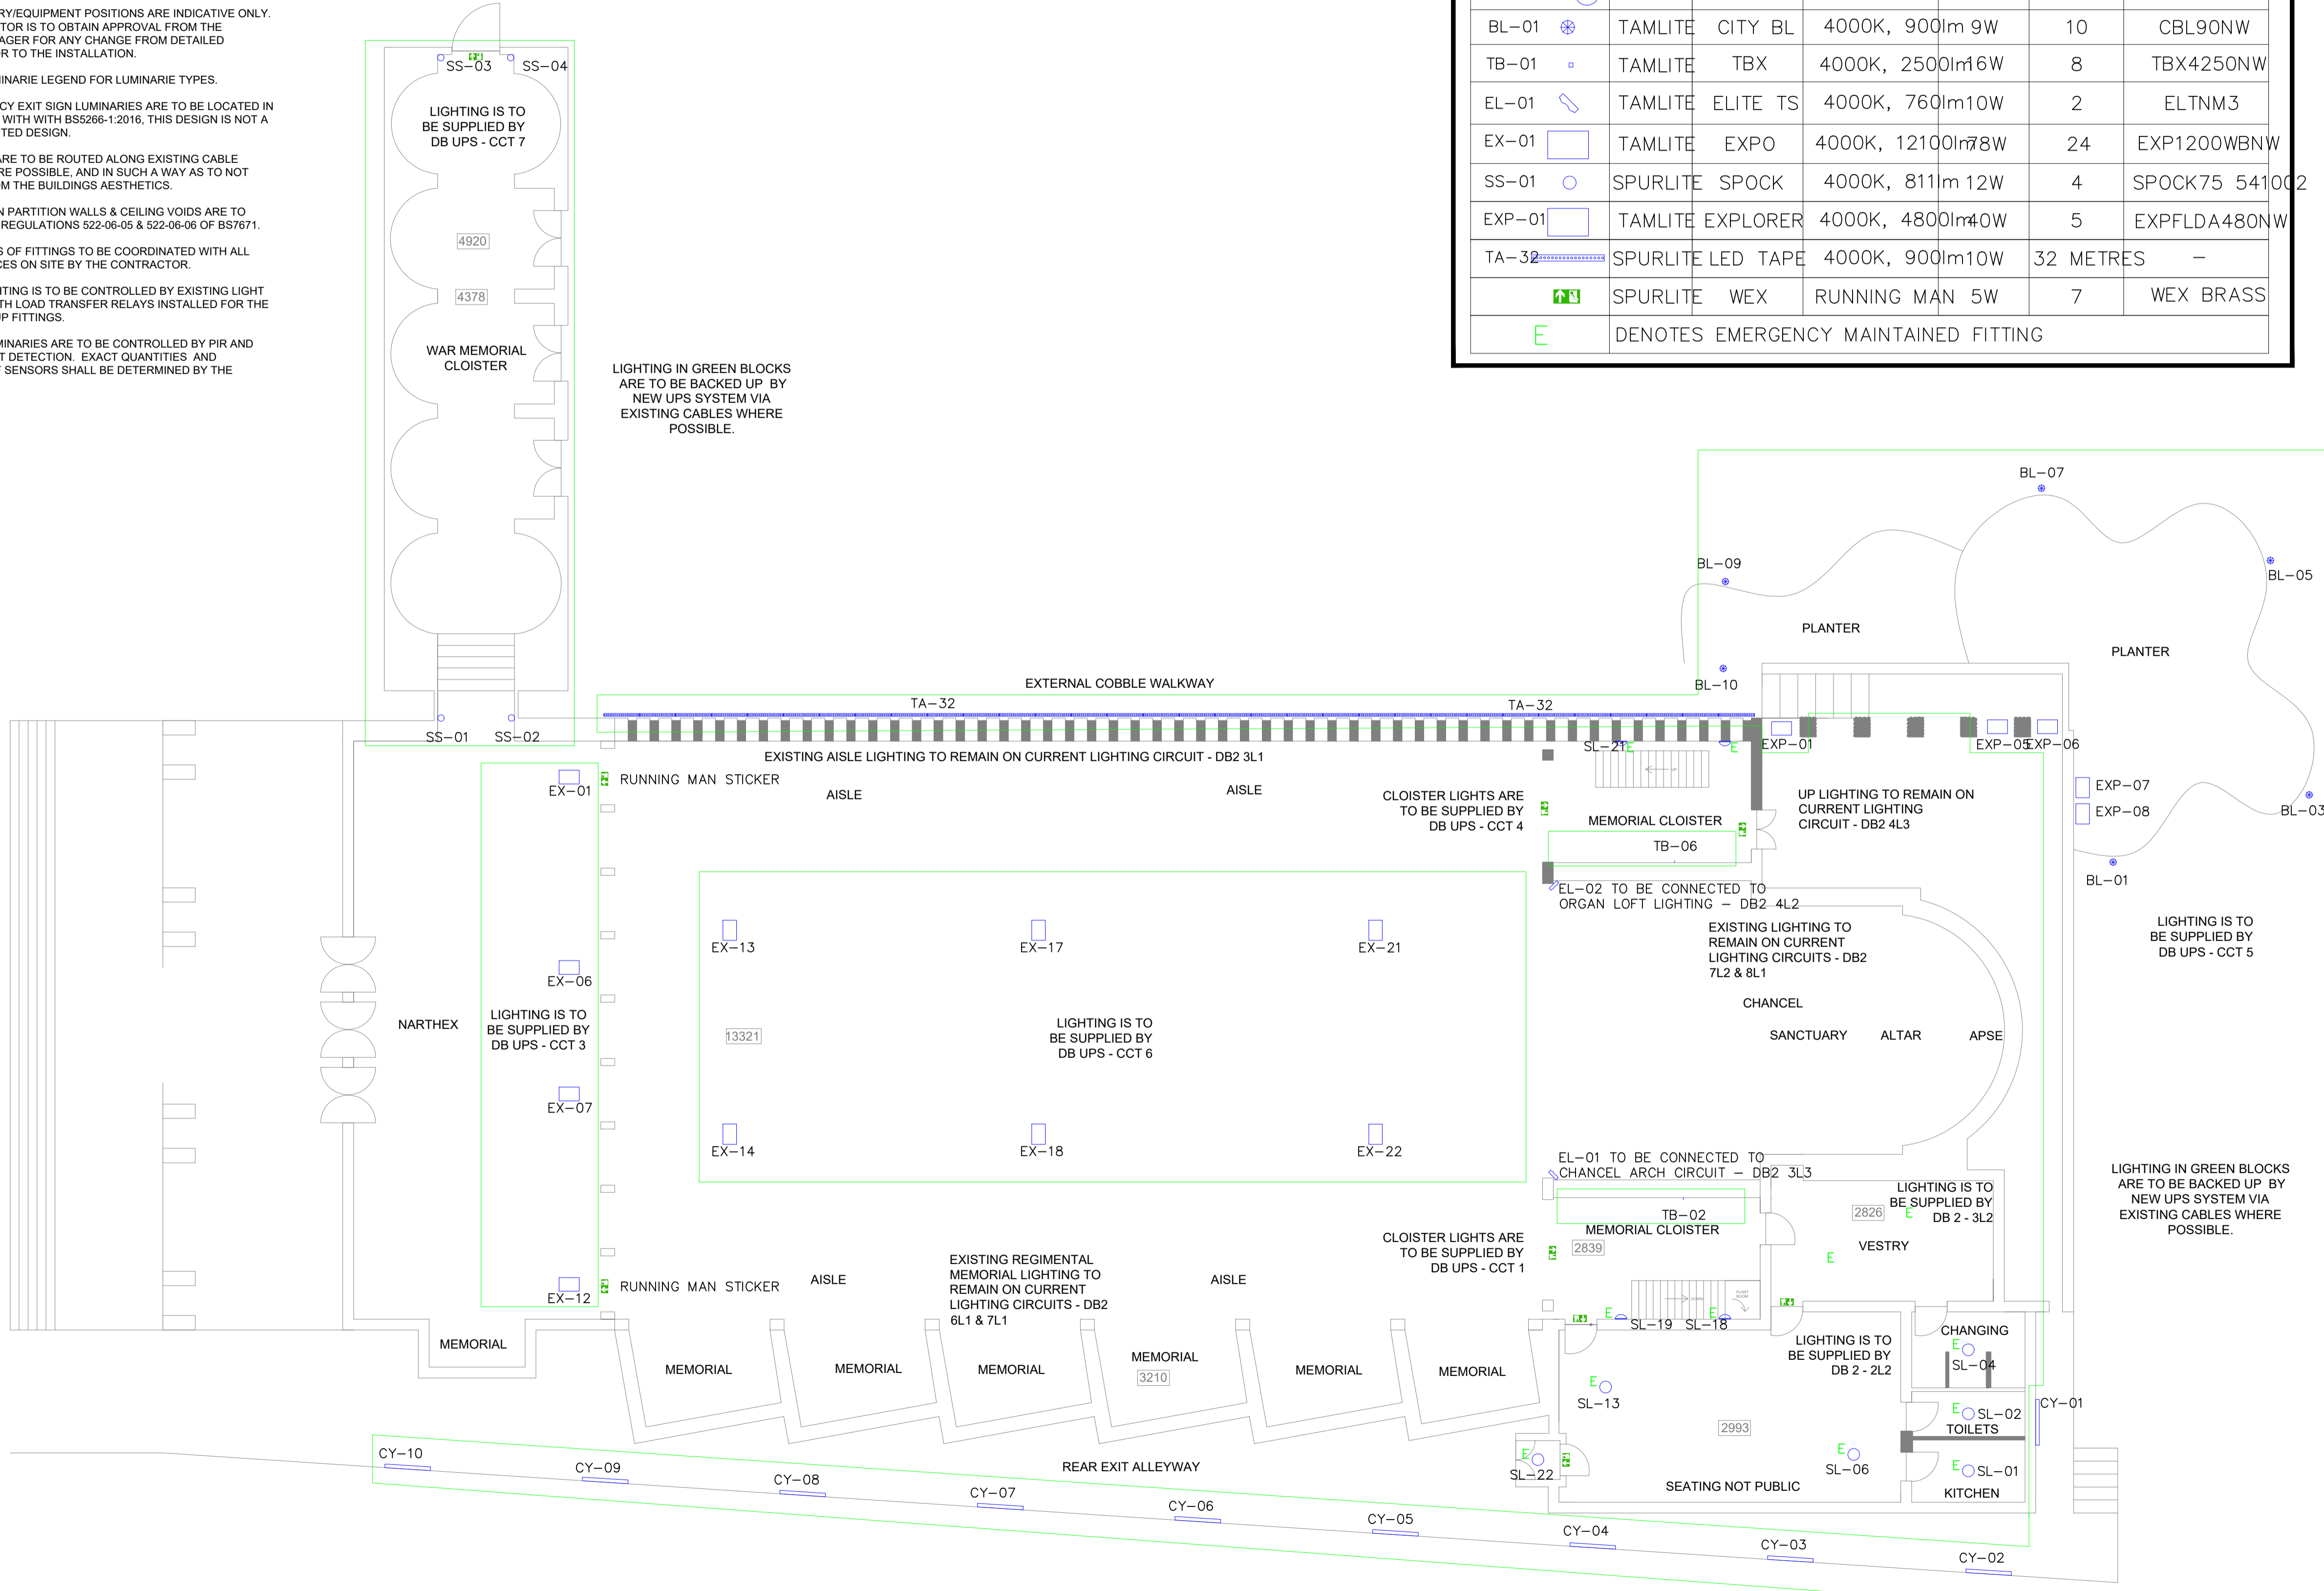

| | |
|---------------------|------|
| ISSUED FOR APPROVAL | DATE |
| DESCRIPTION | |
| REVISIONS | |

STATUS: ISSUED FOR APPROVAL



| | |
|-----------------|----------|
| CLIENT | DESIGNED |
| PROJECT | DRAWN |
| TITLE | CHECKED |
| SCALE | REVISION |
| CONTRACT NUMBER | |
| DATE | |
| DRAWING NUMBER | |