


ALL CLIENTS INFOREMATION HAS BEEN REMOVED FROM THIS DRAWING.

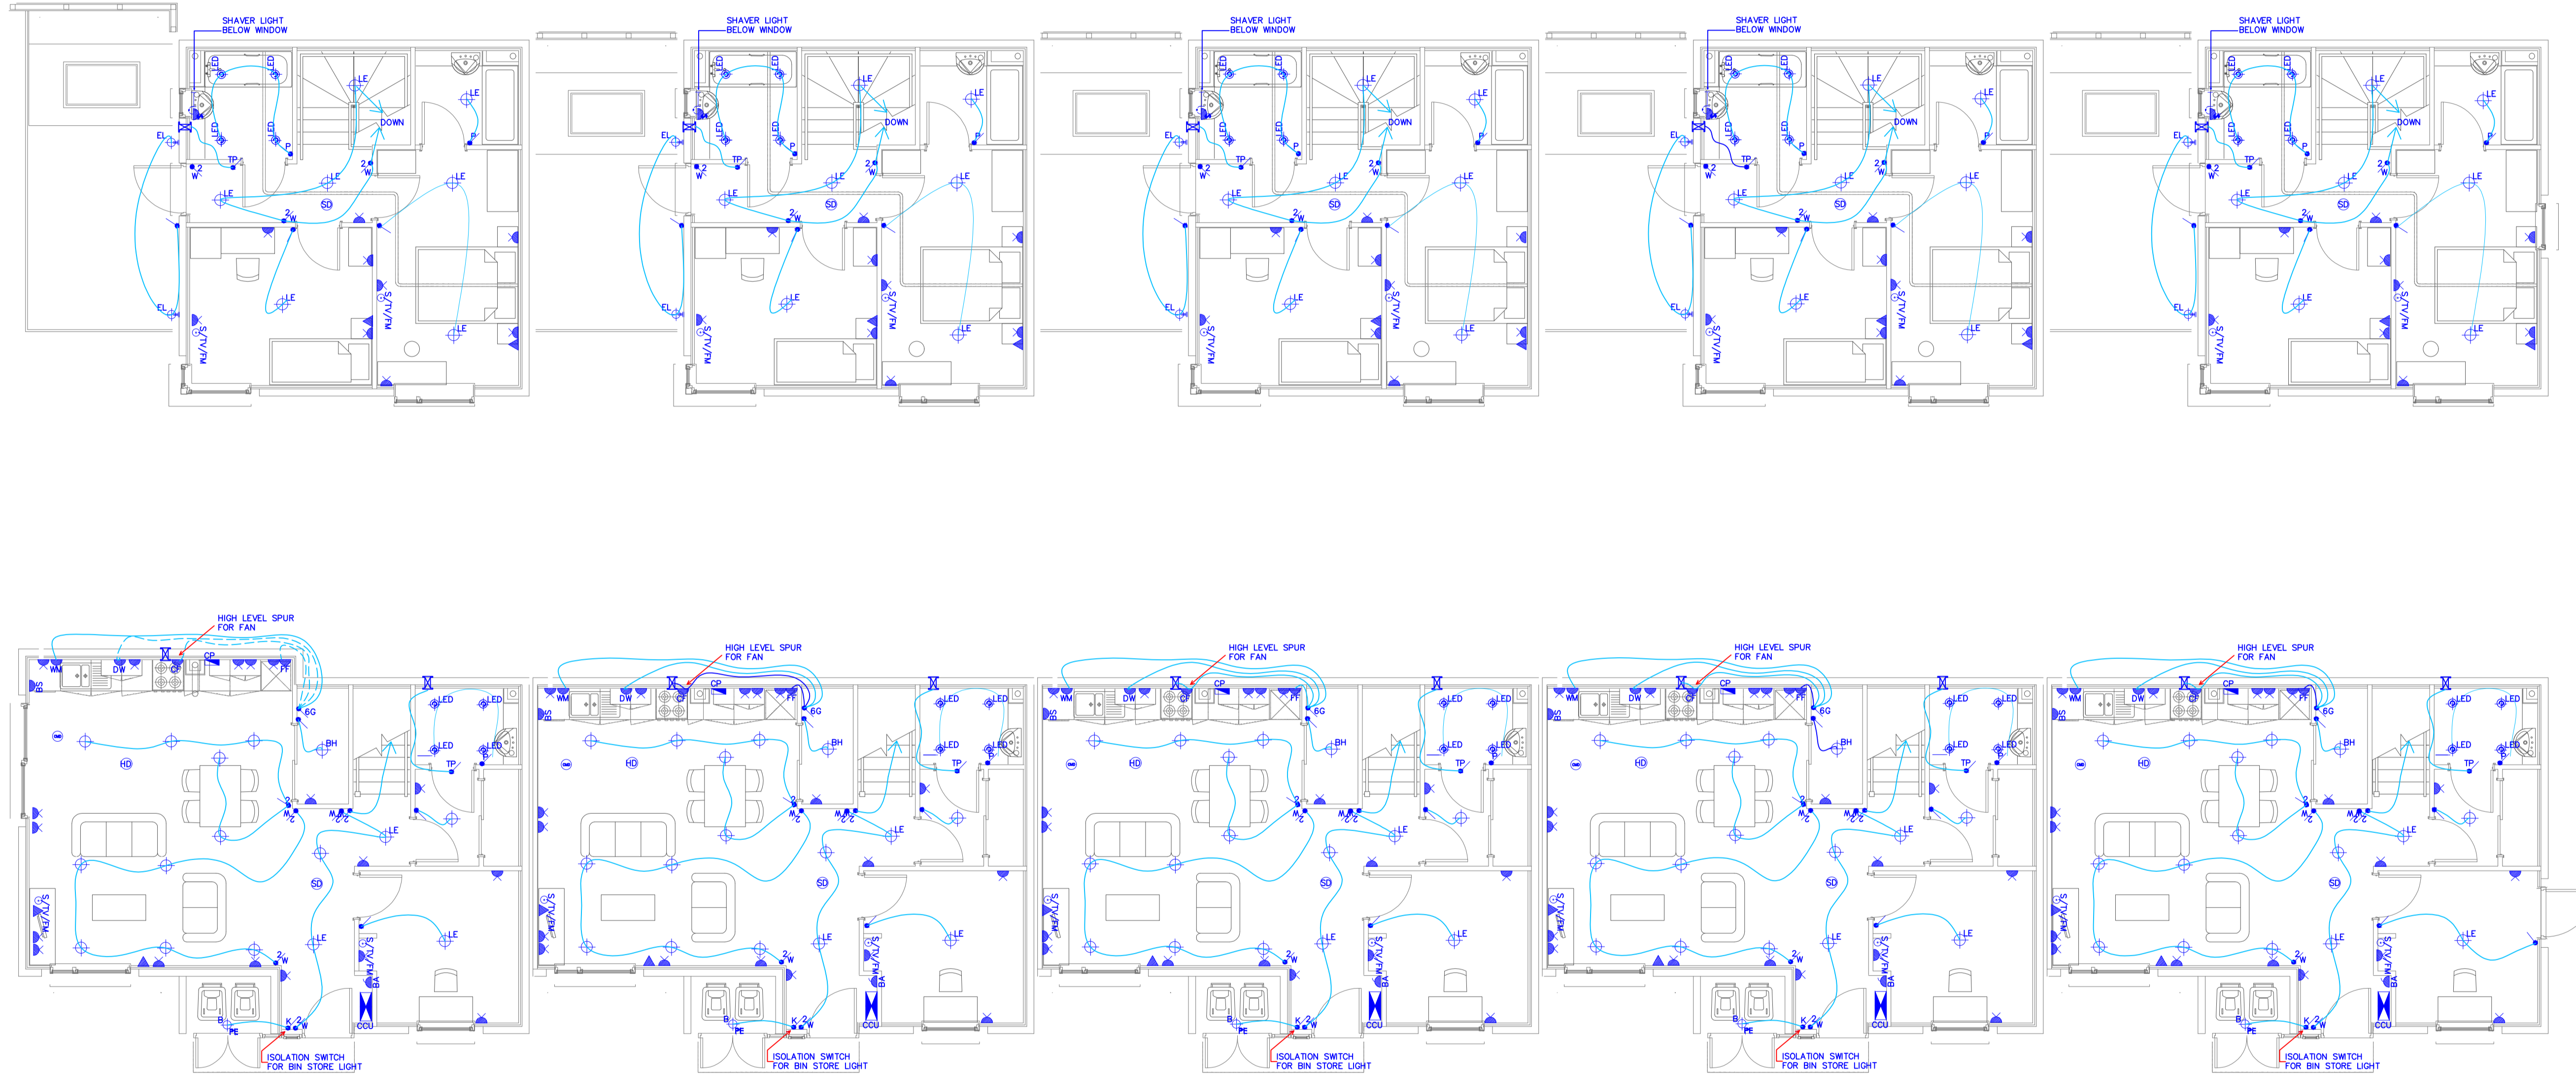

- ELECTRICAL LEGEND**
- ⊕ DOUBLE SOCKET OUTLET
  - ⊕ DOUBLE SOCKET OUTLET AT HIGH LEVEL
  - ⊕ SINGLE SOCKET
  - ⊕ LOCKABLE CLEANERS DOUBLE SOCKET
  - ⊕ 5 AMP SOCKET OUTLET
  - ⊕ 5 AMP SOCKET OUTLET AT HIGH LEVEL
  - ⊕ DUAL VOLTAGE SHAVER SOCKET
  - ⊕ SHOWER SOCKET OUTLET
  - ⊕ WATERPROOF EXTERNAL SOCKET
  - ⊕ 80 AMP SWITCHED FUSE AT HIGH LEVEL
  - ⊕ SWITCHED FUSED SPUR AT HIGH LEVEL
  - ⊕ SWITCHED FUSED SPUR FOR WATER SOFTENER
  - ⊕ SWITCHED FUSED SPUR AT LOW LEVEL
  - ⊕ FUSE OUTLET AT LOW LEVEL
  - ⊕ HIGH LEVEL 5 AMP SWITCH FOR LOW LEVEL SOCKET
  - ⊕ FANUC BUTTON
  - ⊕ ILLUMINATED MANS POWERED DOOR BELL
  - ⊕ DOOR BELL BUZZER
  - ⊕ ENTRY PHONE
  - ⊕ ISOLATOR SWITCH FOR EXTRACT FAN
  - ⊕ HANCOCK HEATER
  - ⊕ BOILER PROGRAMMER
  - ⊕ THERMOSTAT CONTROL
  - ⊕ BURGLAR ALARM KEY PAD
  - ⊕ BURGLAR ALARM CONTROL PANEL
  - ⊕ BURGLAR ALARM SOUNDER
  - ⊕ PASSIVE INFRARED DETECTOR
  - ⊕ PASSIVE INFRARED DETECTOR
  - ⊕ SATELLITE TV PLUMB AERIAL SOCKET
  - ⊕ TELEPHONE JACK SOCKET
  - ⊕ BROADBAND SMART CABLEING
  - ⊕ LIGHT SWITCH
  - ⊕ 2 WAY LIGHT SWITCH
  - ⊕ DIMMER LIGHT SWITCH
  - ⊕ FAN ISOLATION SWITCH
  - ⊕ PULL CORO SWITCH
  - ⊕ SWITCH WITH BELL INDICATOR
  - ⊕ NB: ALL LOW LEVEL SOCKETS TO BE POSITIONED 30MM ABOVE OUTGOING ALL LIGHT SWITCH PLATES ARE TO BE AT 1000MM ABOVE FFL
  - ⊕ LOW ENERGY RECESSED DOWNLIGHT
  - ⊕ LOW ENERGY PENDANT LIGHT
  - ⊕ LOW ENERGY FLUORESCENT
  - ⊕ LED IP RATED DOWNLIGHT
  - ⊕ WINDOW LIGHT
  - ⊕ LED LIGHT FITTING ON DOOR CONTACT SWITCH
  - ⊕ NEON INDICATOR SWITCH TO LEFT LIGHT
  - ⊕ IP55 RATED LIGHT WITH PLASTIC DIFFUSER
  - ⊕ EXTERNAL WALL LIGHT
  - ⊕ EXTERNAL LIGHT FITTING WITH PIR SENSOR
  - ⊕ BATTERY HOLDER FITTING
  - ⊕ BULBHEAD ON PHOTO ELECTRIC SENSOR
  - ⊕ BULBHEAD ON PHOTO ELECTRIC SENSOR (EMERGENCY)
  - ⊕ SHAVER LIGHT
  - ⊕ 800000000 CAT 2 LIGHT FITTING
  - ⊕ COOKER PANEL
  - ⊕ CUSTOMER CONSUMER UNIT
  - ⊕ DOOR CONTACT FOR BURGLAR ALARM
  - ⊕ EXTRACT FAN WITH 15 MIN. OVERSUN TRIP. CHIMP LINEAR RUNNING FAN (15 LITRE BARBROOM) (10 LITRE STOVEN)
  - ⊕ MANS OPERATED AUTOMATIC SMOKE DETECTOR FITTING. 100MM SPREAD 300MM AWAY FROM LIGHT FITTINGS & 1000MM AWAY FROM ANY PERIMETER WALL
  - ⊕ MANS OPERATED AUTOMATIC HEAT DETECTOR FITTING. 100MM SPREAD 300MM AWAY FROM LIGHT FITTINGS & 1000MM AWAY FROM ANY PERIMETER WALL
  - ⊕ CARBON MONOXIDE DETECTOR
  - ⊕ SWITCHED FUSED SPUR FOR FUTURE POSE
  - ⊕ HOST TRANSFORMER
  - ⊕ SWITCHED FUSED SPUR FOR BURGLAR ALARM
  - ⊕ SWITCHED FUSED SPUR FOR FUTURE ELECTRIC FIRES
  - ⊕ SWITCHED FUSED SPUR FOR TUBULAR HEATER
  - ⊕ FOR CENTRAL EXTRACT UNIT
  - ⊕ LINE OFFICE AREA - INCLUDING 2x2 DOUBLE SOCKETS AND BT OUTLET
  - ⊕ FAN - SWITCHED FUSED SPUR FOR PUMPED DRAINAGE
  - ⊕ TOWEL RADIATOR
  - ⊕ HEATED TOWEL RAIL (ELECTRIC)
  - ⊕ TUBULAR HEATER
  - ⊕ GAS METER
- \* ALL SOCKETS EXCEPT HOSE AT HIGH LEVEL TO BE MOUNTED 300MM ABOVE FFL (TO BOTTOM EDGE)  
 \* ALL SWITCHES TO BE MOUNTED 1200 MM ABOVE FFL (TO BOTTOM EDGE)  
 \* SINGLE SOCKETS AT LOW LEVEL AS PER NOTE  
 \* FUTURE FREEZE PROOFER FOUR FAN  
 \* WASHING MACHINE

ISSUED FOR APPROVAL	DATE
DESCRIPTION	
REVISIONS	

STATUS ISSUED FOR APPROVAL



CLIENT	
PROJECT	
TITLE	
SCALE	DESIGNED
CONTRACT NUMBER	DRAWN
DATE	CHECKED
DRAWING NUMBER	REVISION